

1080 Marina Village Parkway
Suite 501
Alameda, CA 94501-1142

ISSUES / REVISIONS


[illegible]

CONTRA COSTA
COMMUNITY
COLLEGE DISTRICT


Drawn by	Author
Scale	As indicated

HVAC CONTROLS DRAWINGS


BAS.01

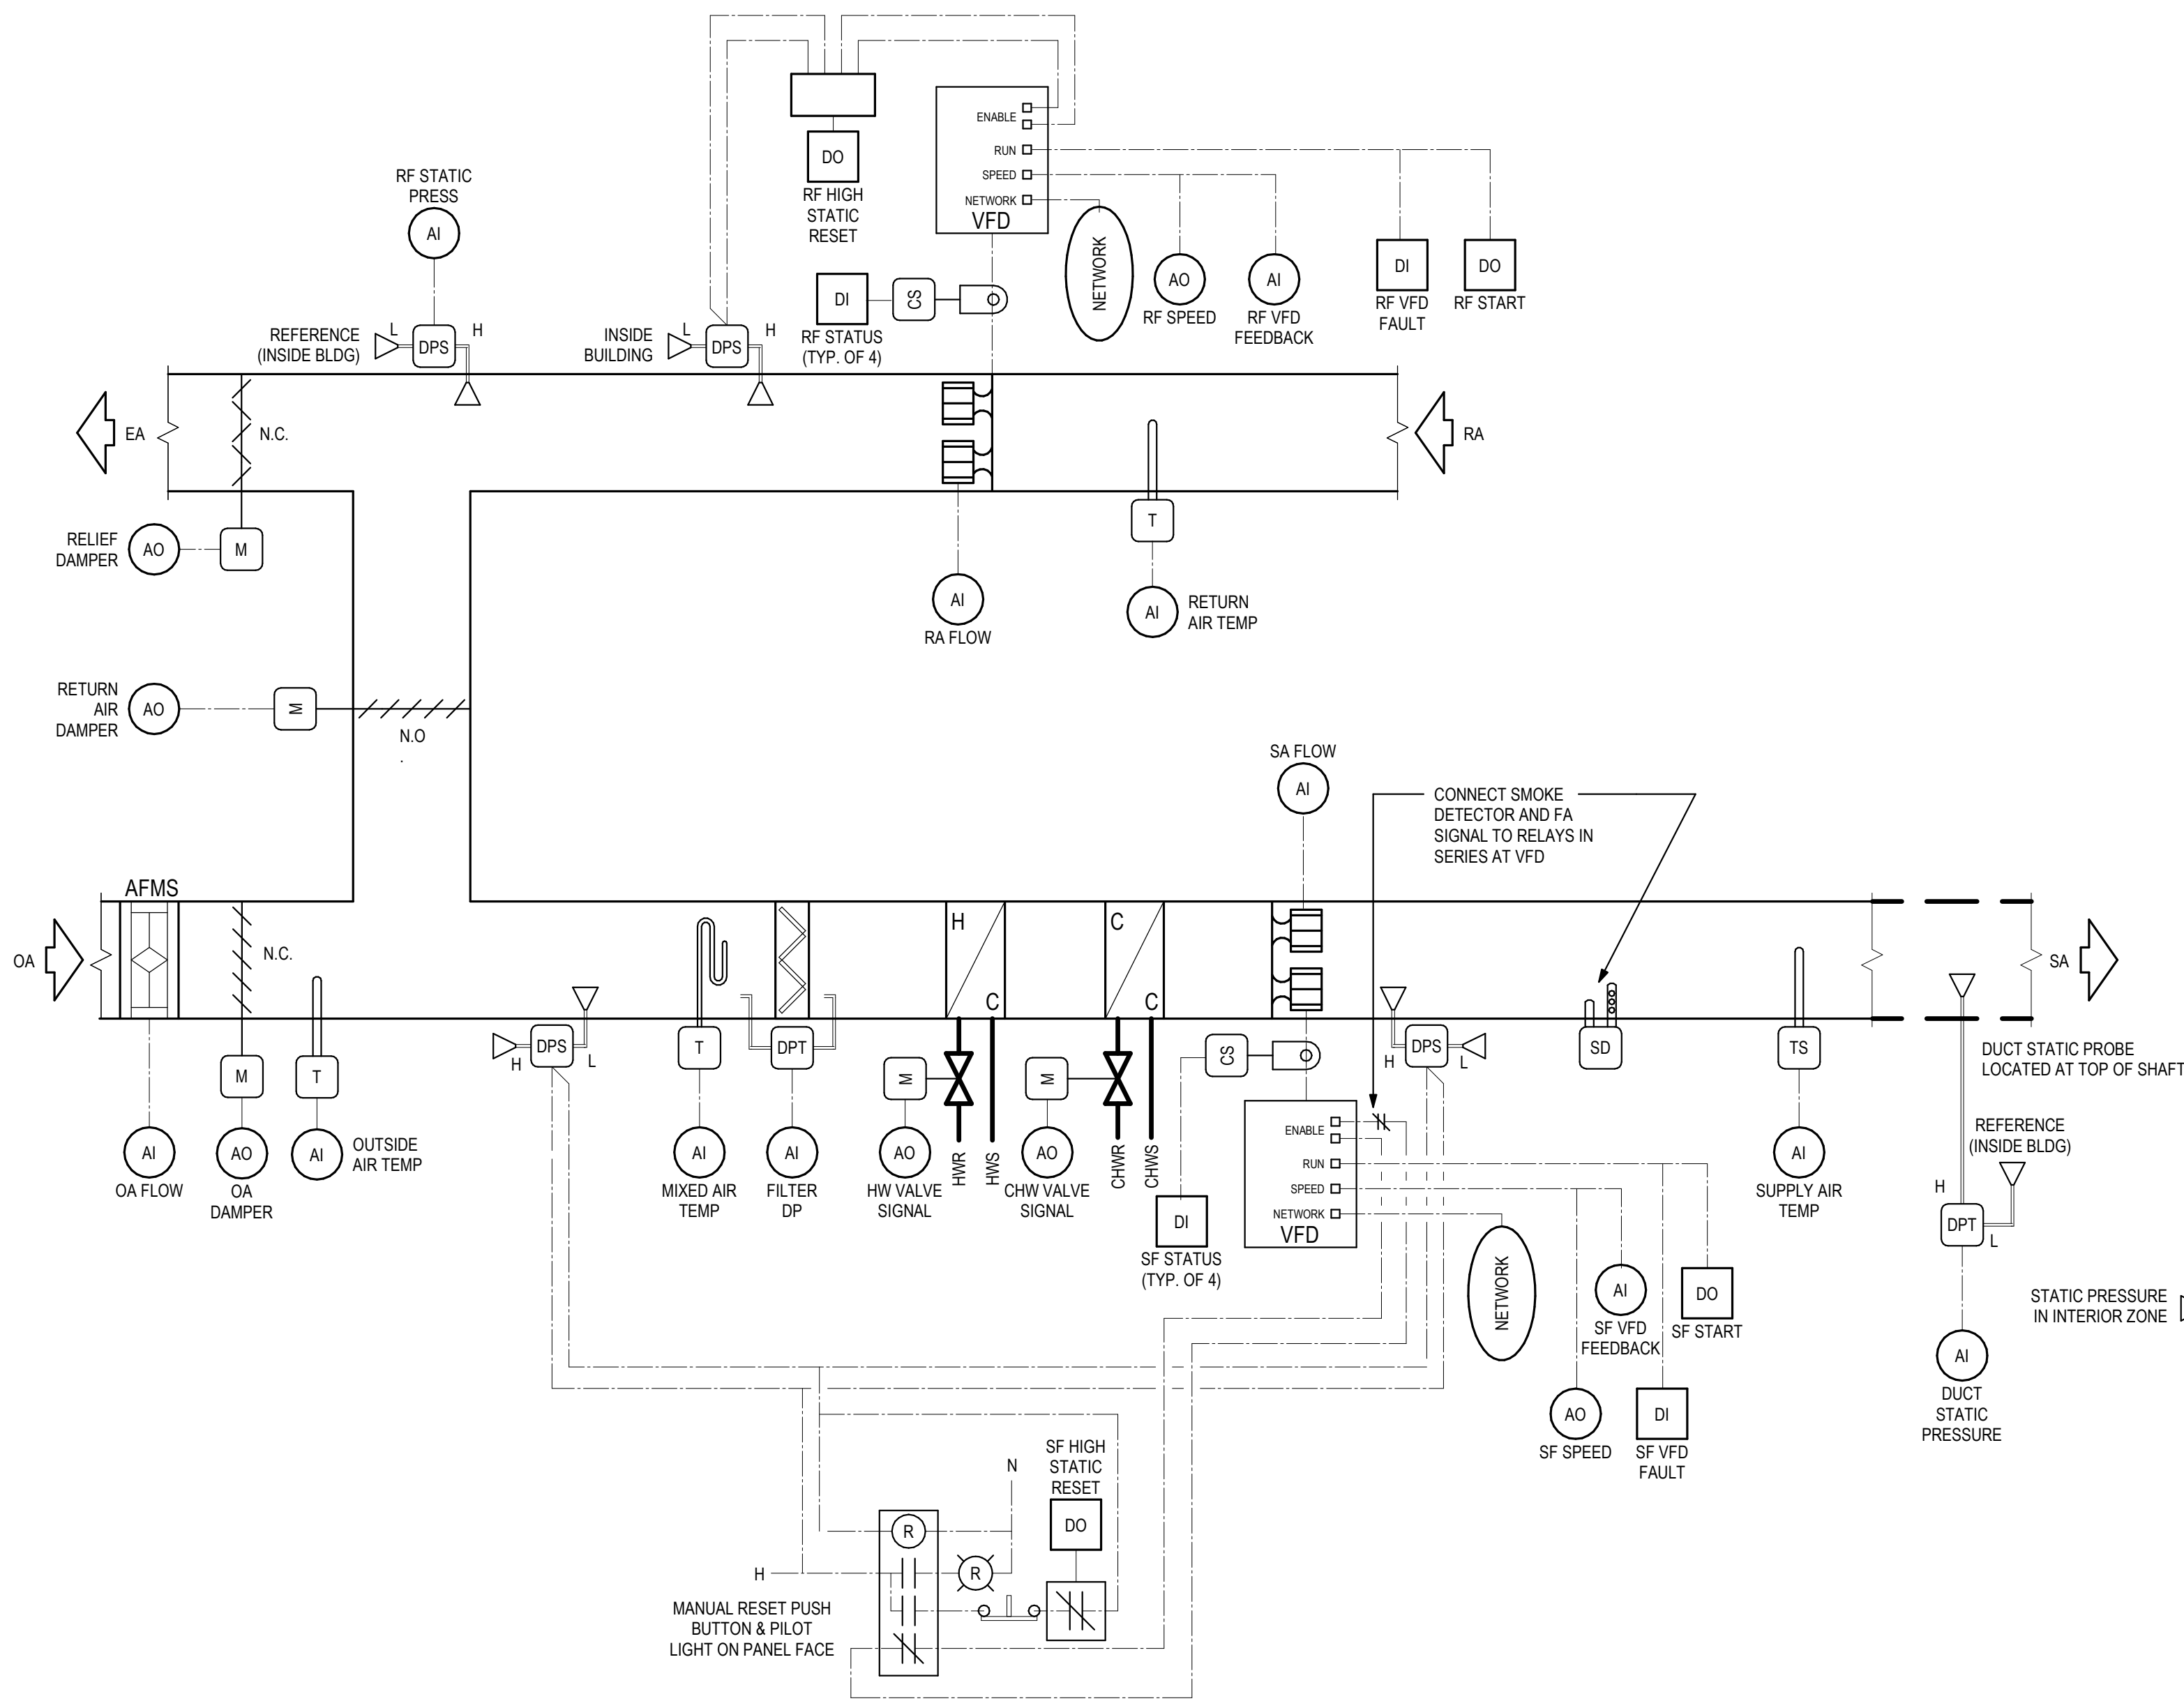


1 VAV AIR HANDLER WITH RETURN FAN AND HW/CHW COILS

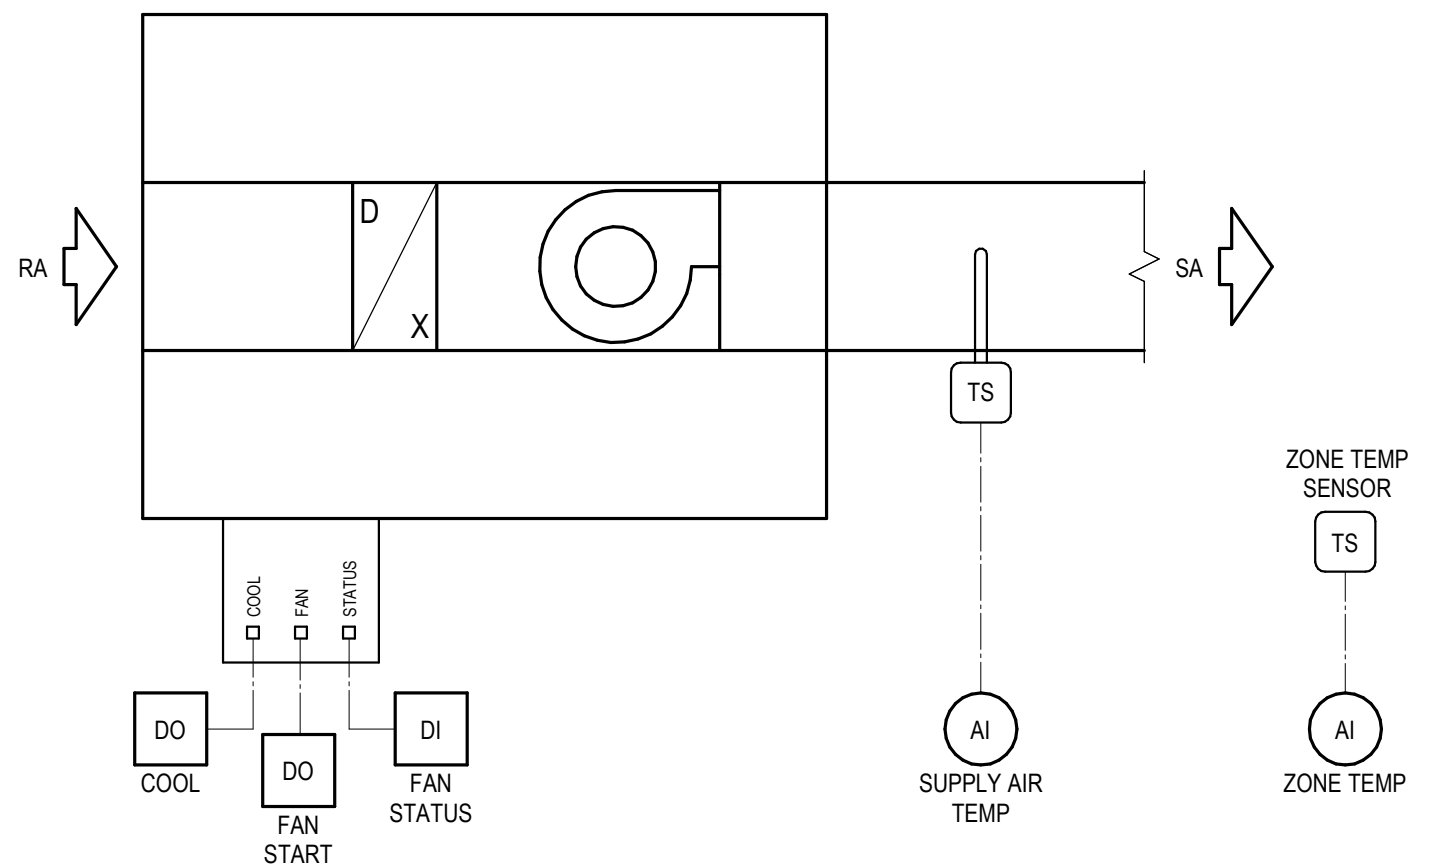



2 PACKAGED AC UNIT OR HEAT PUMP

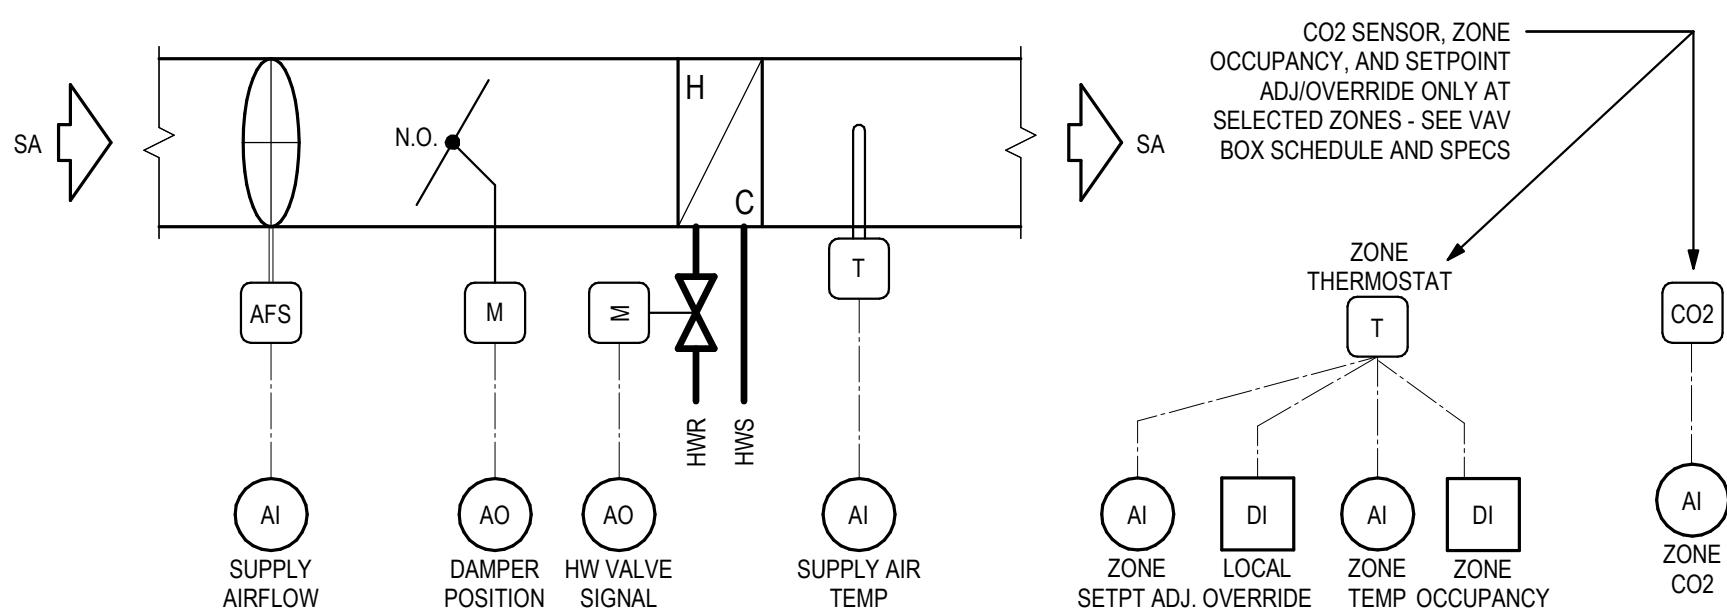

3 VAV REHEAT ZONE - EXISTING DDC AND PNEUMATIC

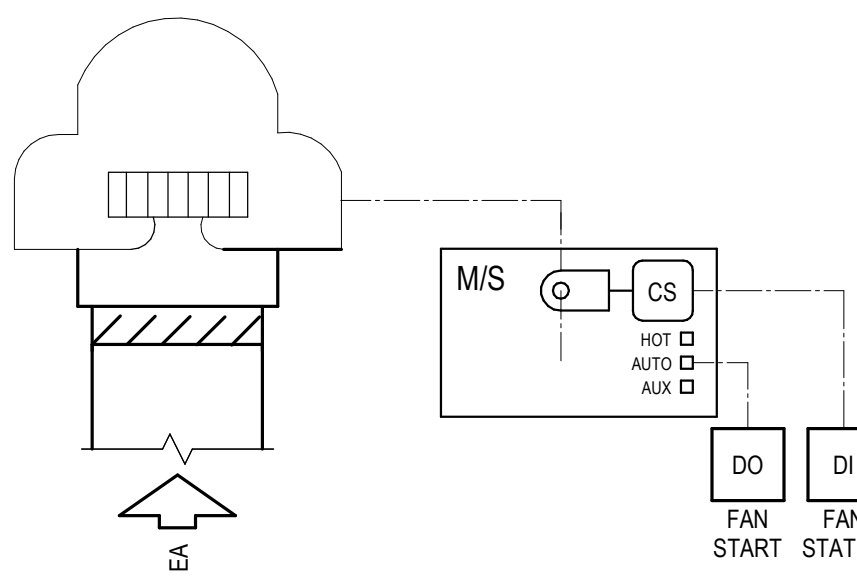

4 ROOF EXHAUST FAN

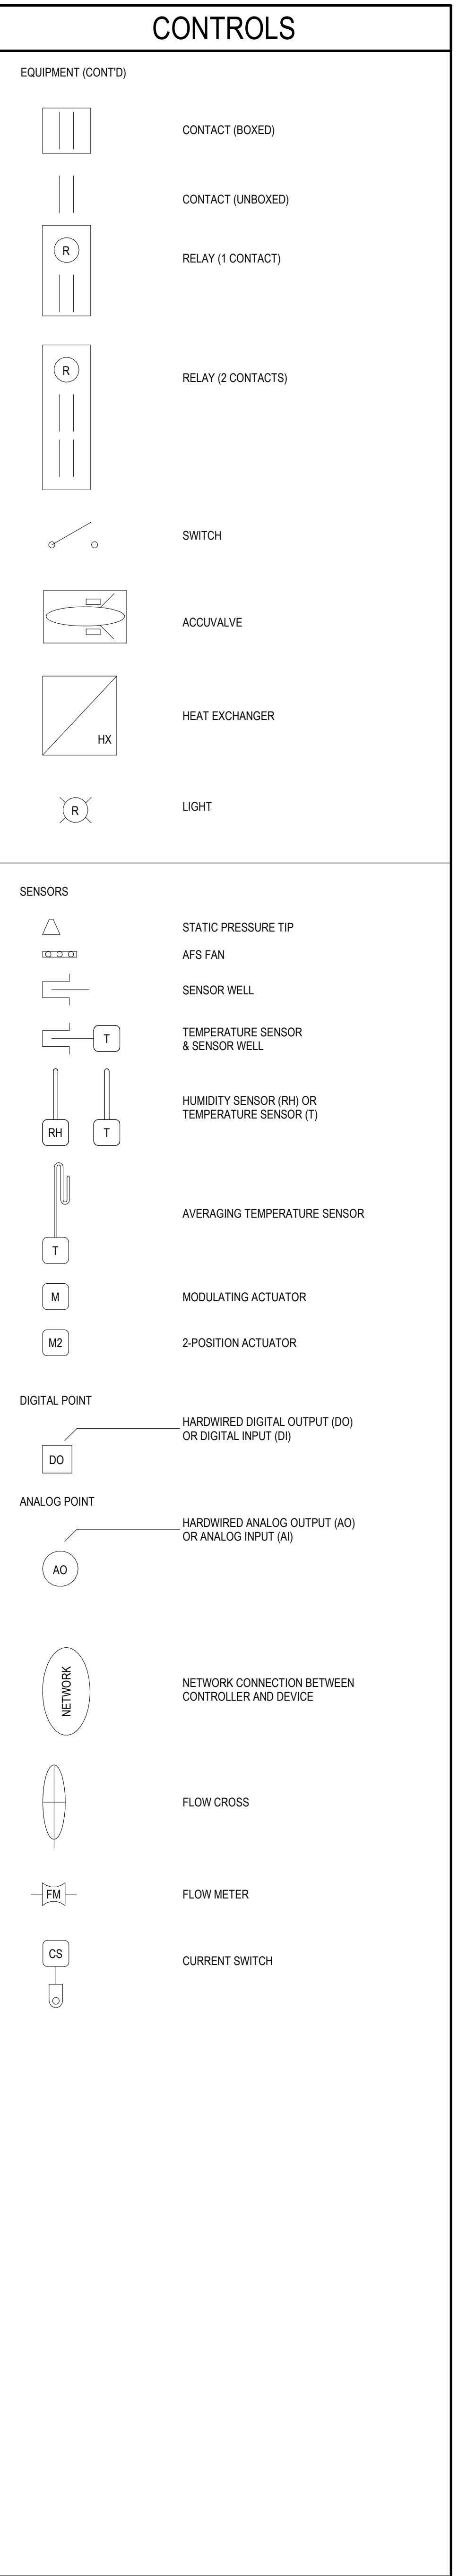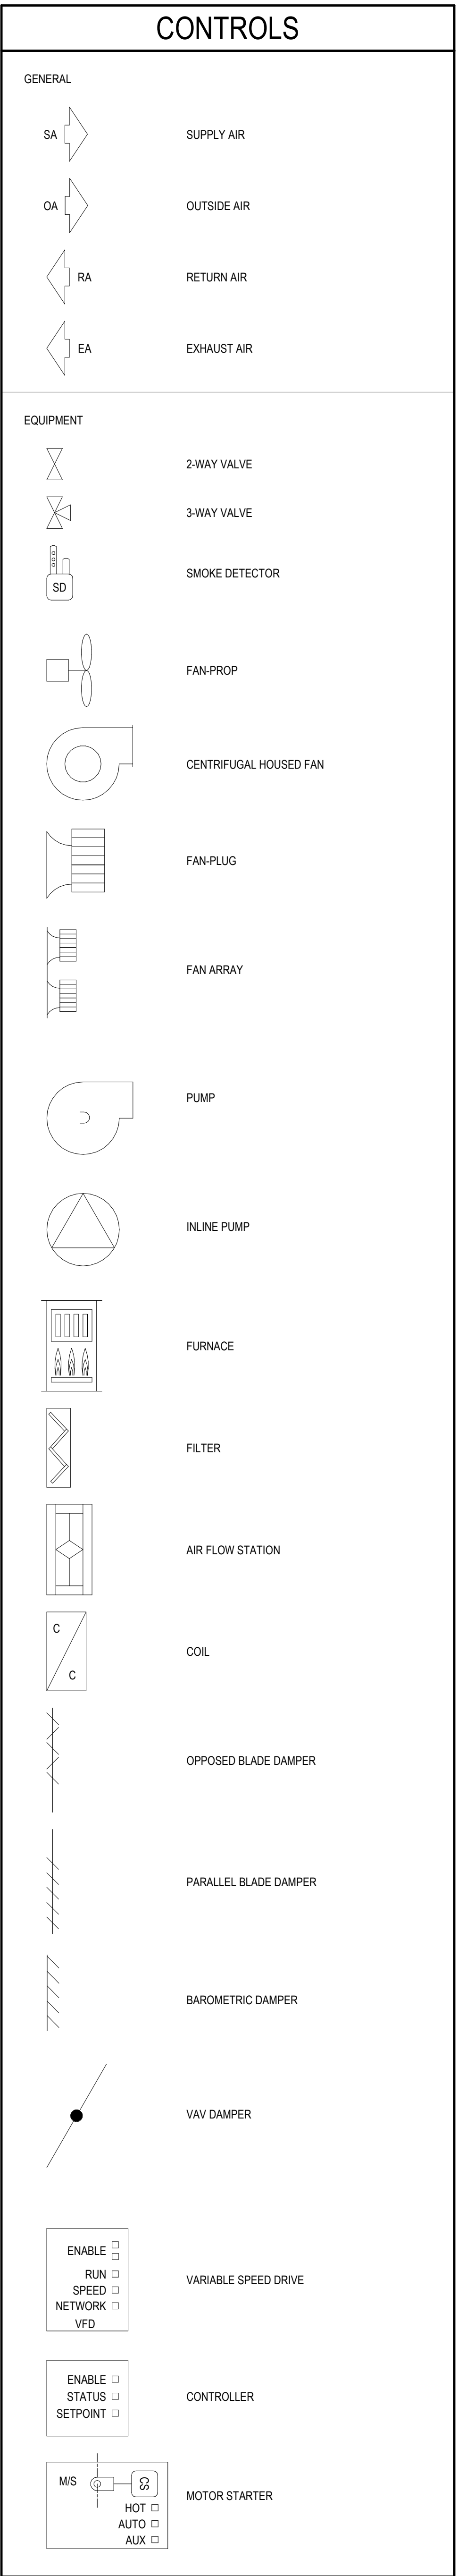

taylor | engineers

 
1080 Marina Village Parkway
Suite 501
Alameda, CA 94501-1142

[illegible]

CONTRA COSTA
COMMUNITY
COLLEGE DISTRICT

SECTOR 5B FLOOR PLAN

M.01



taylor | engineers

1080 Marina Village Parkway
Suite 501
Alameda, CA 94501-1142

TAMP

ISSUES / REVISIONS

[illegible]

CONTRA COSTA
COMMUNITY
COLLEGE DISTRICT

Drawn by	Author
Scale	1/8" = 1'-0"

SECTOR 13 FLOOR PLAN

M.02